



Calabasas
Los Angeles
Orange County

www.SheridanInc.com
877.874.2012



DATE	DESCRIPTION
01.01.01	Revision 1
01.01.01	Revision 2
01.01.01	Revision 3
01.01.01	Revision 4
01.01.01	Revision 5


FURNITURE PLAN	
drawing title:	FURNITURE PLAN
date created:	8/15/2023
approved by:	WAKEFIELD
signature:	SUSAN
date signed:	person #3,

client:	NLARC
location:	9200 OAKDALE AVENUE CHATSWORTH, CALIFORNIA 91311 1ST FLOOR EXPANSION
sheet:	Sheet 1/1



Calabasas
Los Angeles
Orange County

www.SheridanInc.com
877.874.2012

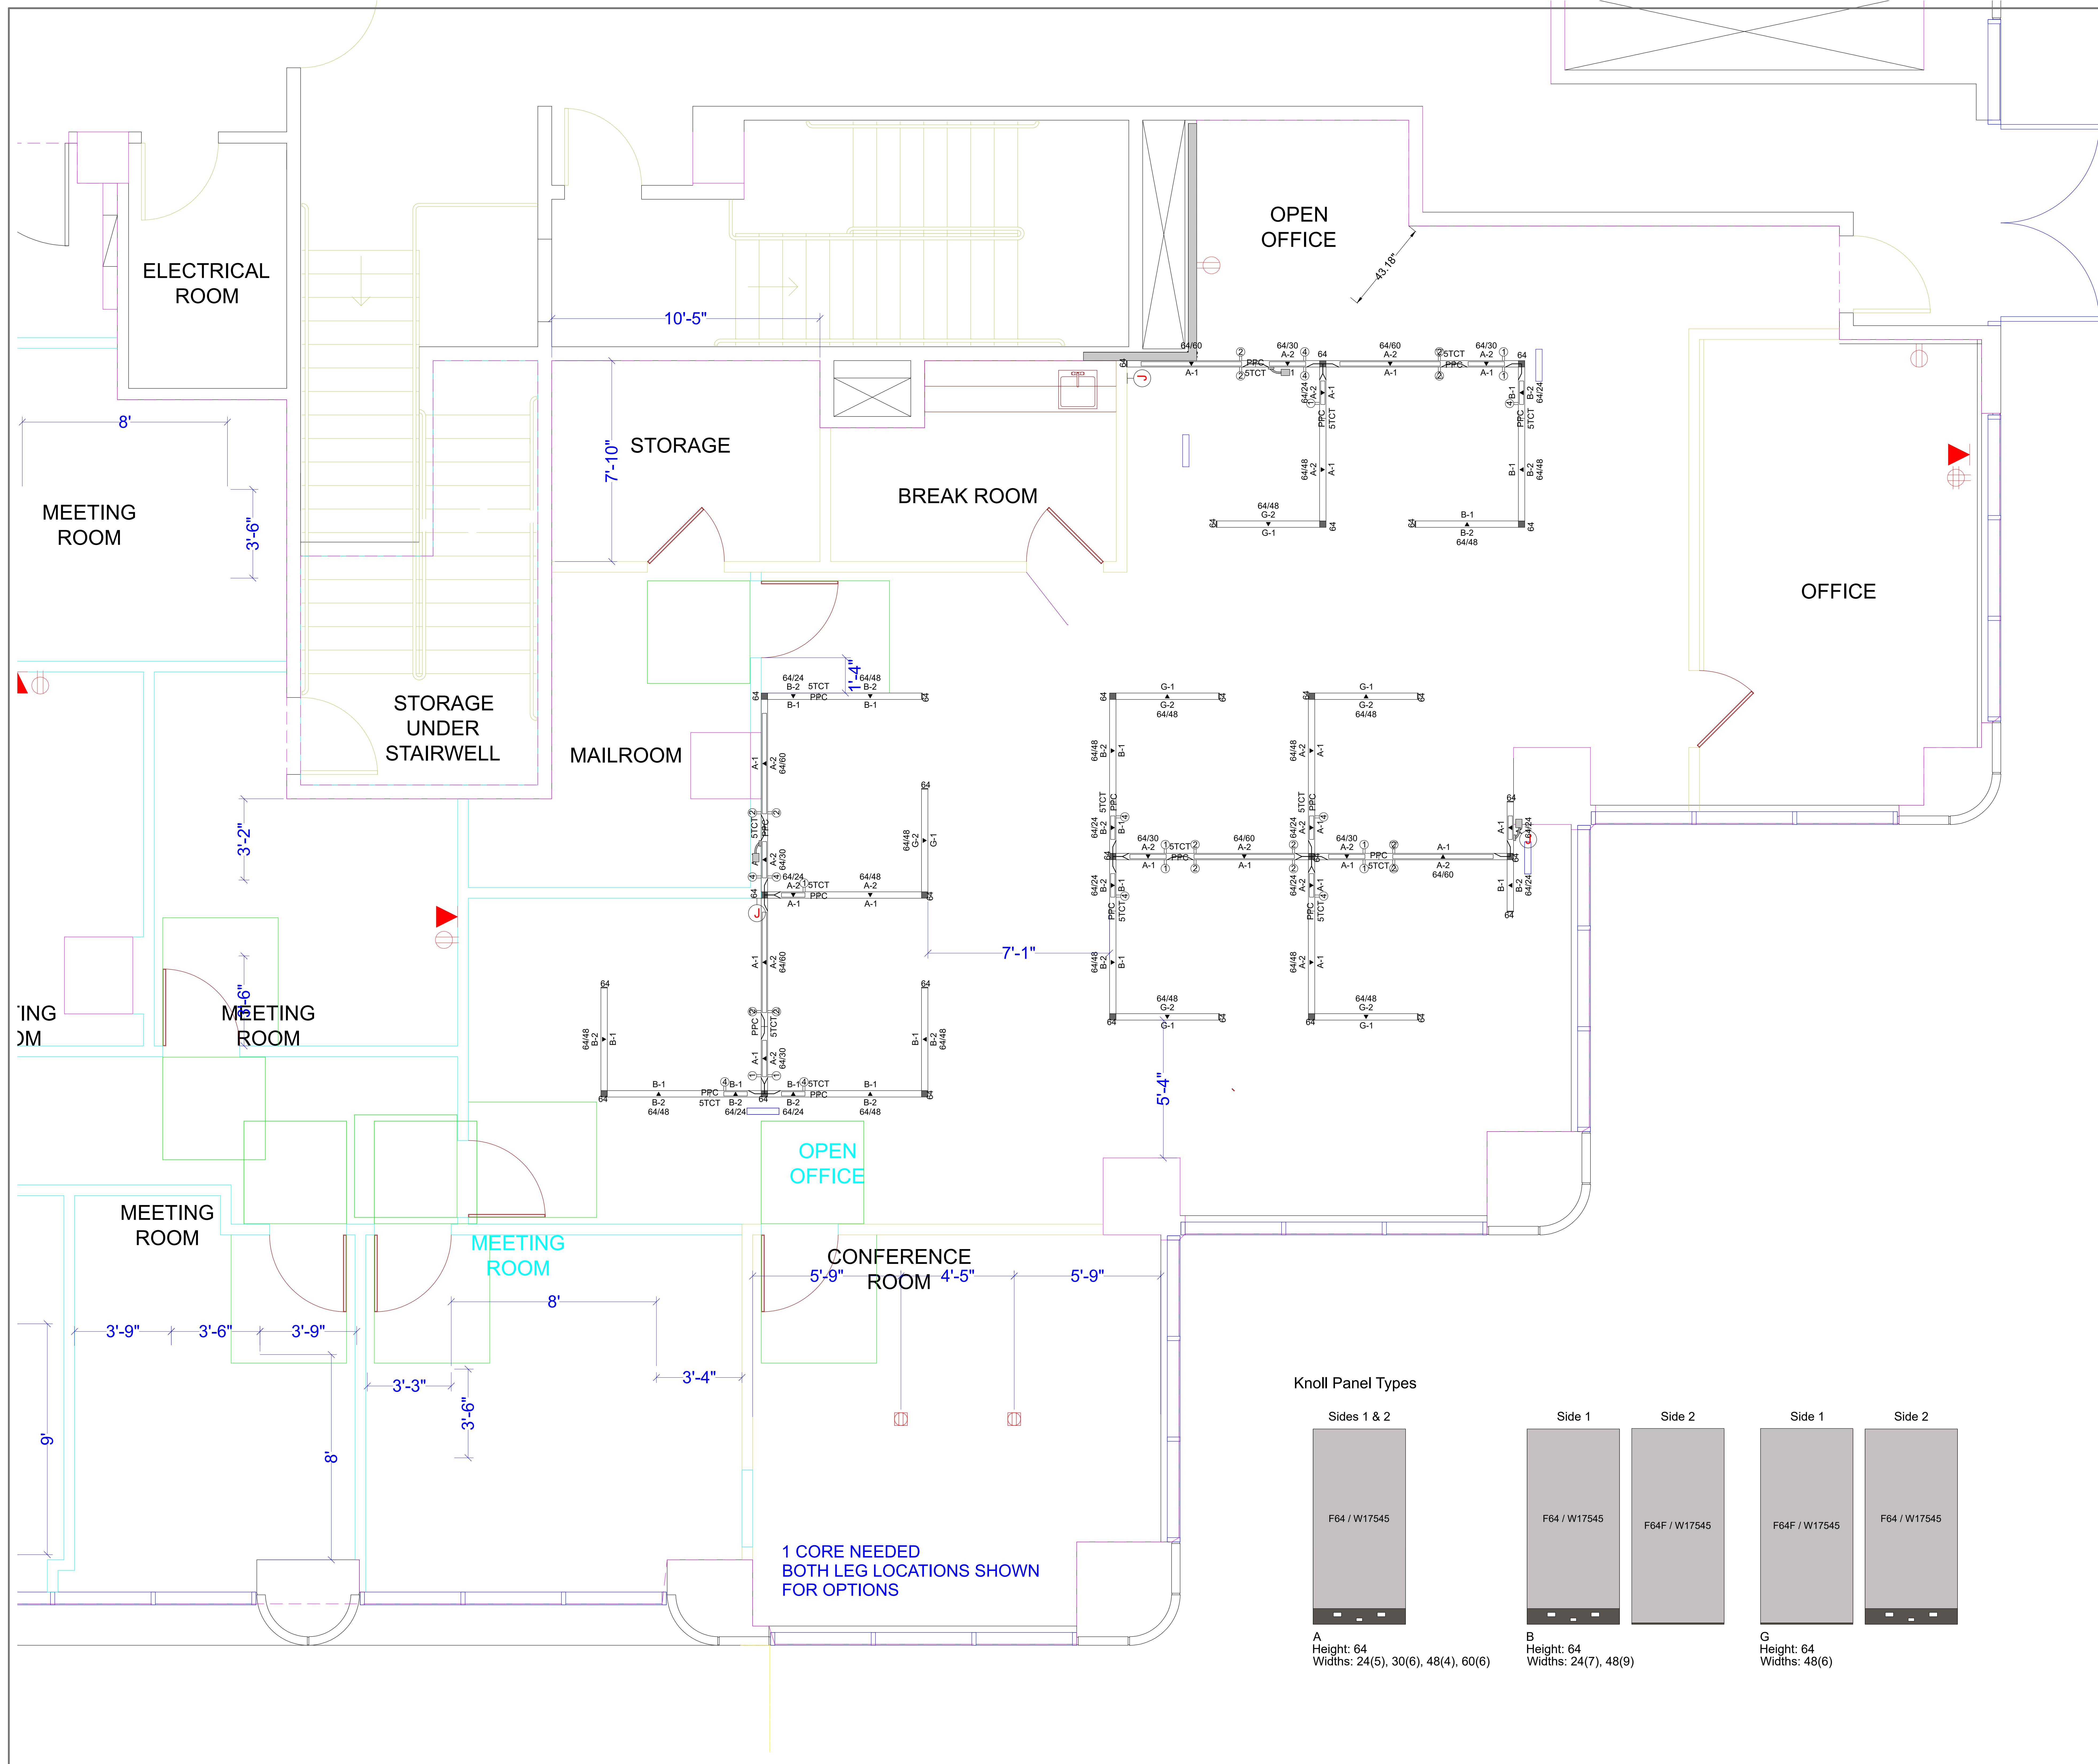


DATE	DESCRIPTION
01.01.01	Revision 1
01.01.01	Revision 2
01.01.01	Revision 3
01.01.01	Revision 4
01.01.01	Revision 5

PANEL & ELECTRICAL PLAN	
date created:	8/15/2023
drawn by:	WAKEFIELD
account:	SUSAN
checked by:	person #3,
approved by:	
signature:	
date signed:	

client:	NLARC
location:	9200 OAKDALE AVENUE CHATSWORTH, CALIFORNIA 91311 1ST FLOOR EXPANSION
sheet:	Sheet 1/1

Knoll Panel Types

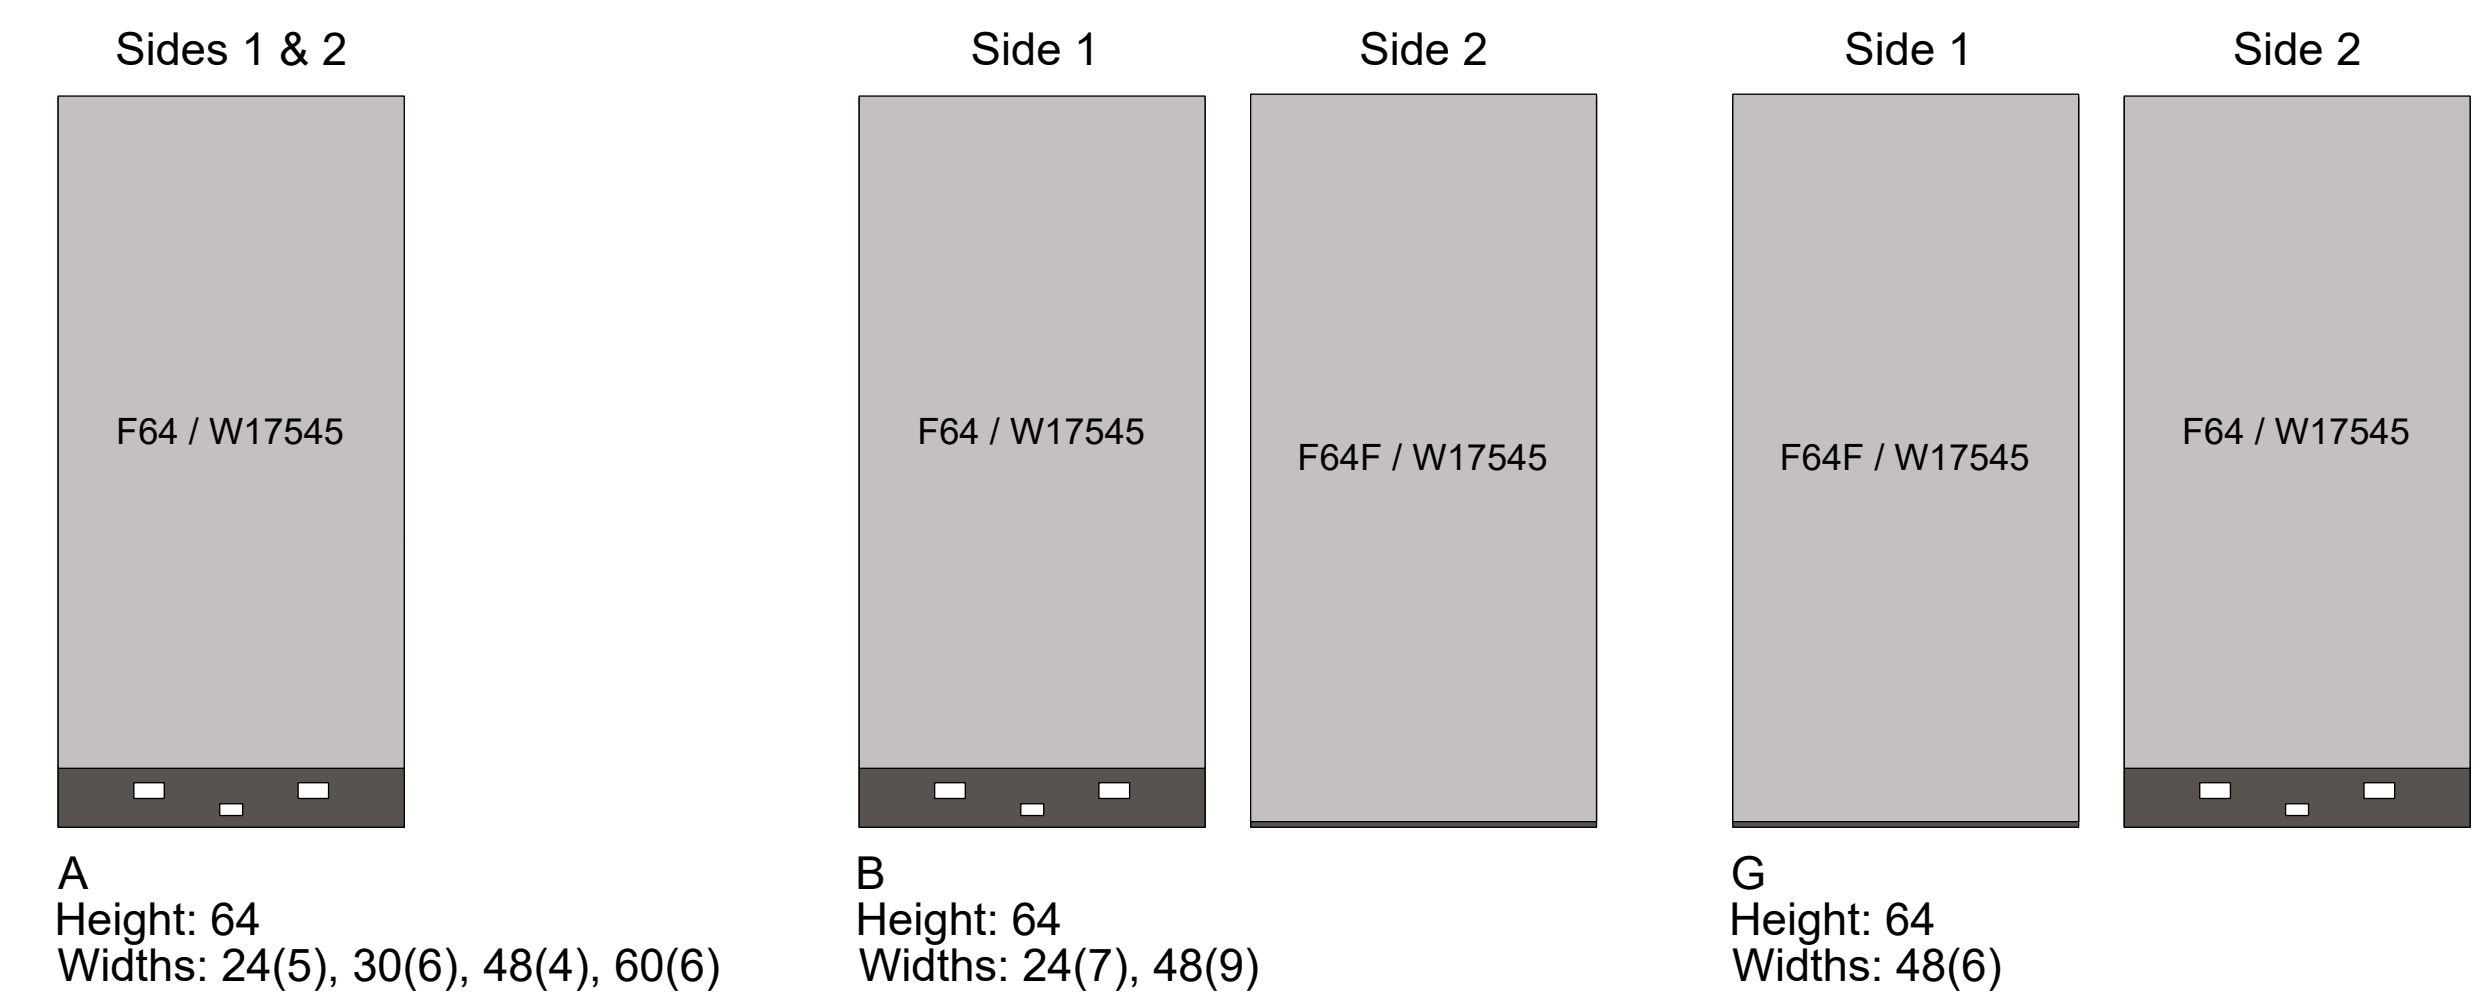


1 CORE NEEDED
BOTH LEG LOCATIONS SHOWN
FOR OPTIONS



Calabasas
Los Angeles
Orange County

www.SheridanInc.com
877.874.2012

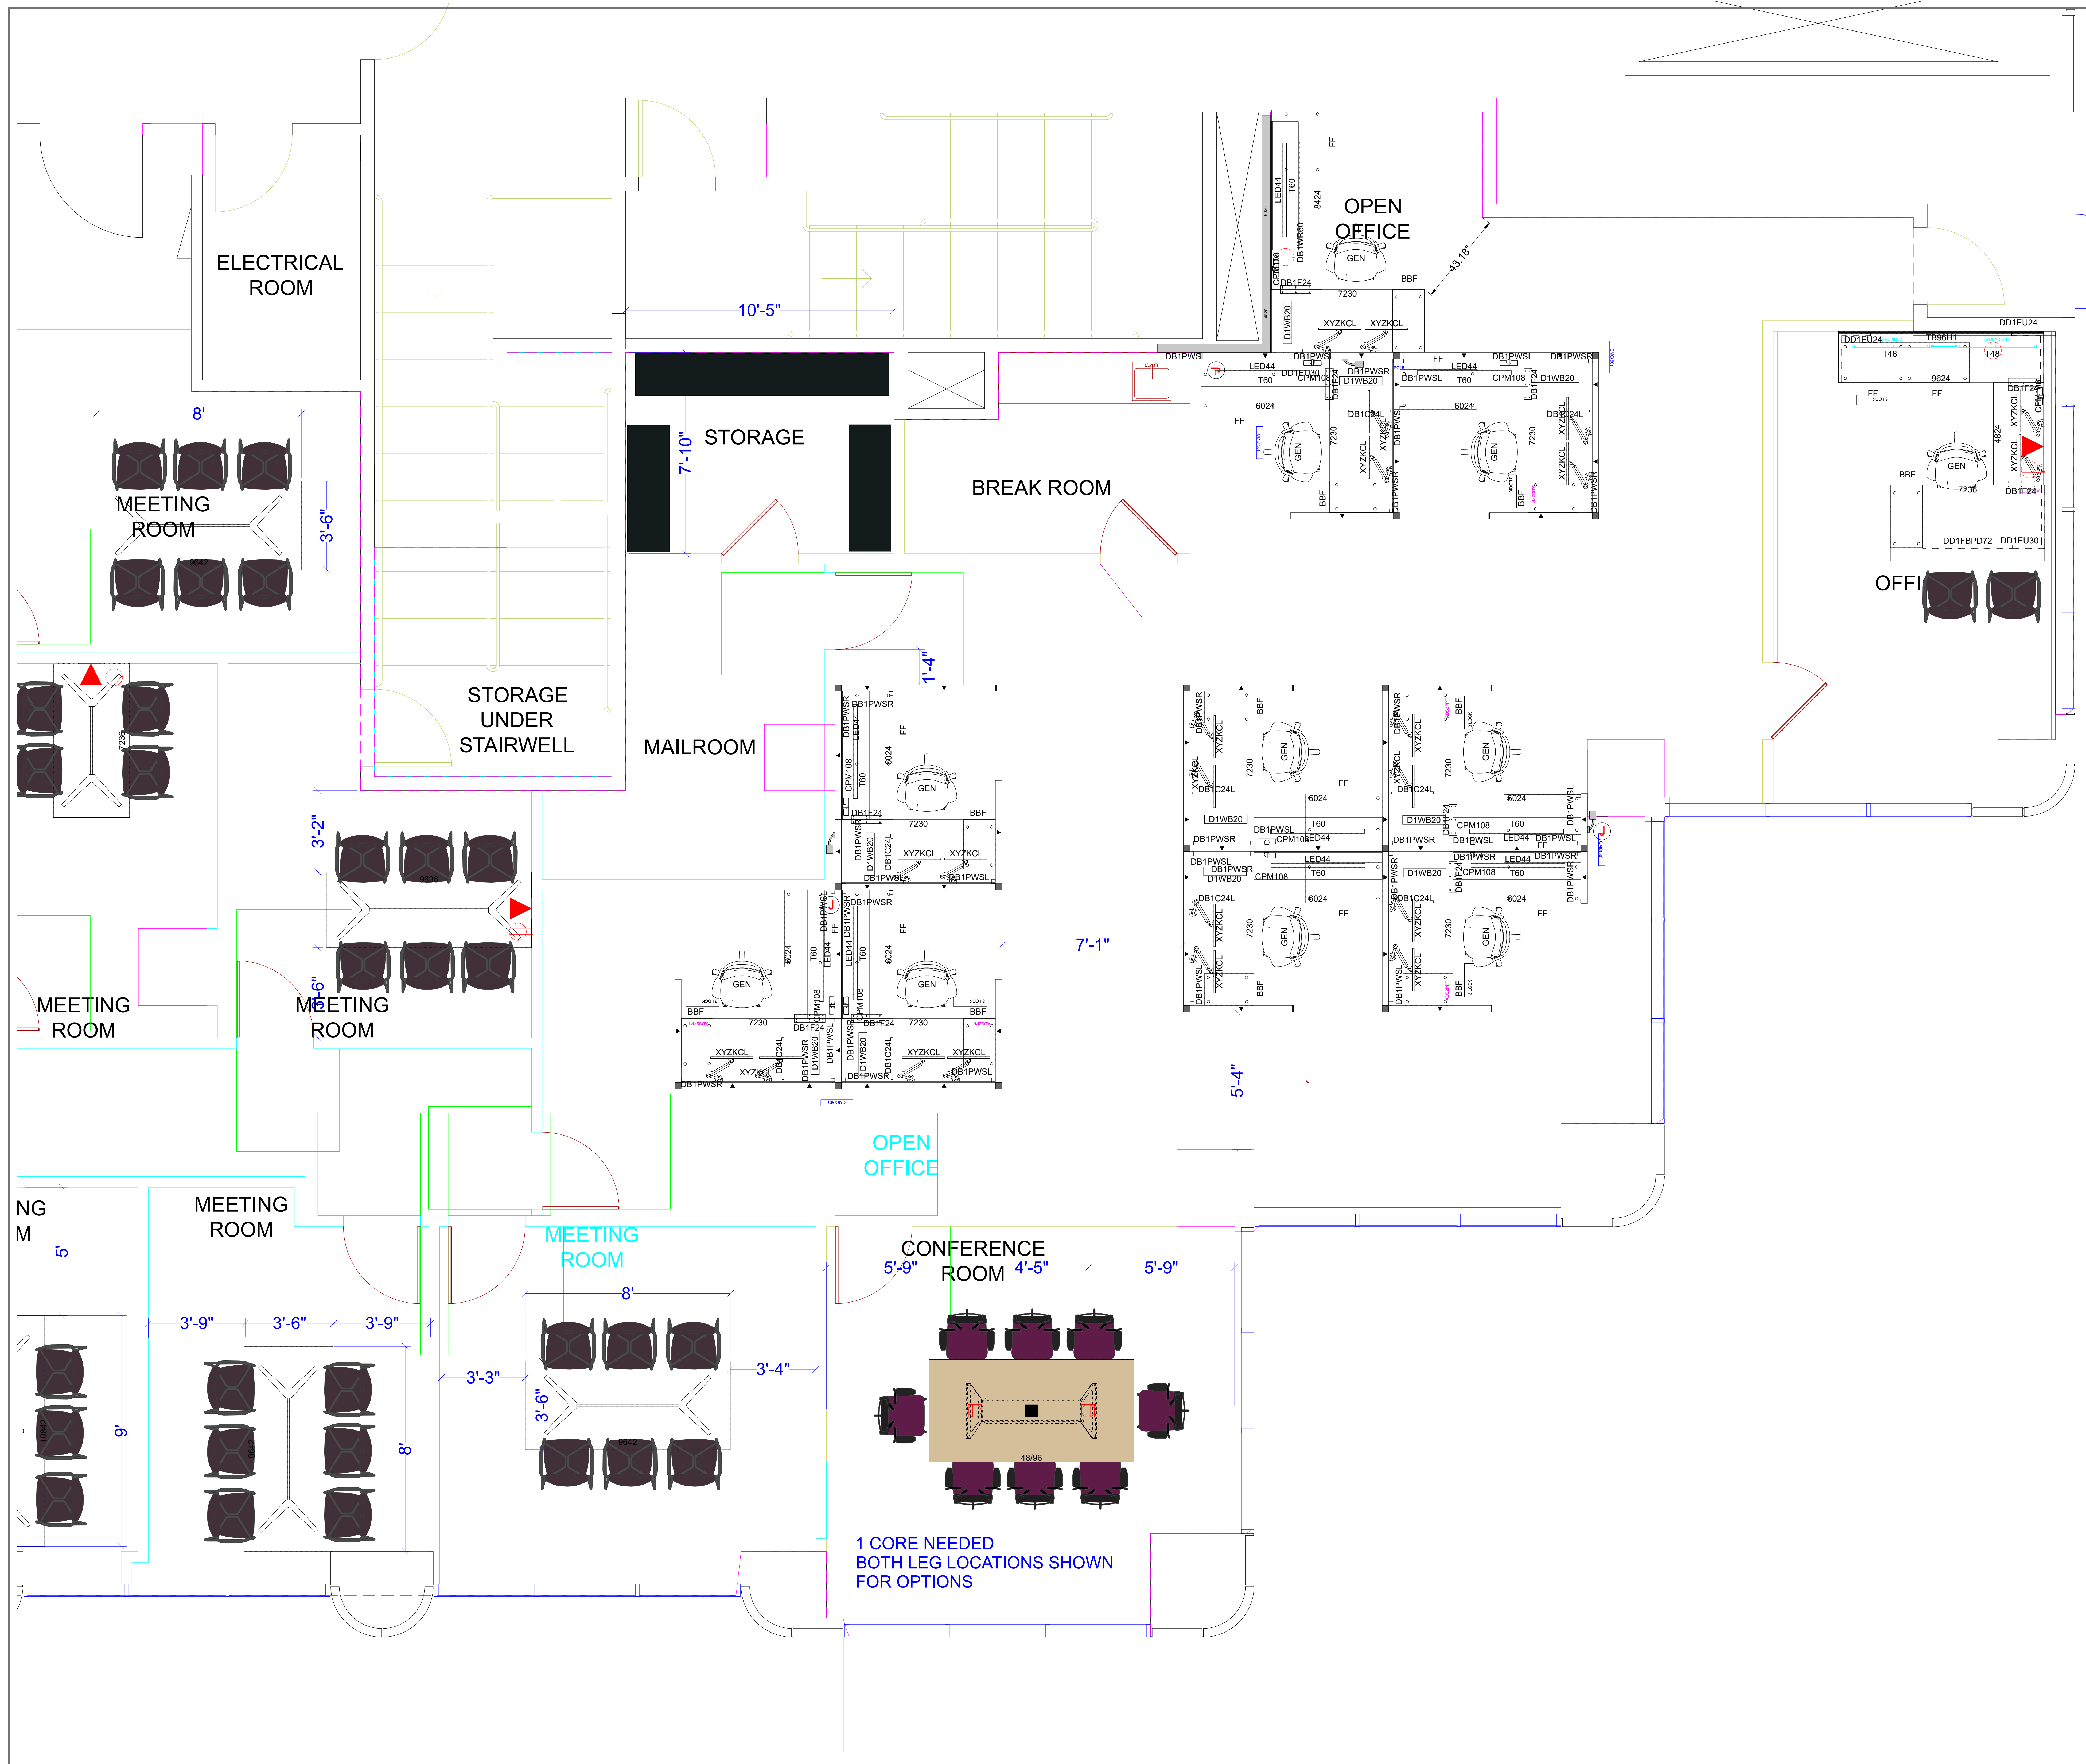

REVISION FIELD:	DATE	DESCRIPTION
Revision 1	01.01.01	
Revision 2	01.01.01	
Revision 3	01.01.01	
Revision 4	01.01.01	
Revision 5	01.01.01	

COMPONENTS PLAN	
drawing title:	COMPONENTS PLAN
date created:	8/15/2023
approved by:	WAKEFIELD
signature:	SUSAN
date signed:	person #3,

client:	NLARC
location:	9200 OAKDALE AVENUE CHATSWORTH, CALIFORNIA 91311 1ST FLOOR EXPANSION
sheet:	Sheet 1/1

1 CORE NEEDED
BOTH LEG LOCATIONS SHOWN
FOR OPTIONS